



REFLECTED CEILING PLAN - AREA "A"  
SCALE: 1/8" = 1'-0"

REFLECTED CEILING LEGEND	
	NON-LOAD BEARING WALL TO TERMINATE INTO CEILING STRUCTURE ABOVE
	1 HR. FIREWALL - WALL TO TERMINATE INTO ROOF SUPPORTS ABOVE (UL DESIGN NO. U305)
	2 HR. FIREWALL - WALL TO TERMINATE INTO ROOF STRUCTURE ABOVE (UL DESIGN NO. U301)
	STRUCTURAL HEADER (SEE STRUCT. DWGS.)
	1/2" GYPSUM CEILING ON CEILING JOISTS @ 10'-0" A.F.F.
	FIBERGLASS REINFORCED PANEL CEILING @ 10'-0" A.F.F.
	1 HR. FIRE RATED CEILING (UL DESIGN NO. L504)
	INDOOR / OUTDOOR CEILING FAN WITH BUILT-IN LIGHT FIXTURE
LIGHT FIXTURE LEGEND	
	8" COMPACT FLOURESCENT CYLINDER, VERTICAL LAMP WITH 8" APERTURE, DIMMABLE SURFACE MOUNTED DOWNLIGHT (MOUNTED ON SLOPED CEILING)
	6" COMPACT FLOURESCENT DOWNLIGHT, VERTICAL LAMP WITH 6" APERTURE, RECESSED MOUNTED DOWNLIGHT (IC-RATED) IN CONTACT WITH INSULATION ABOVE CEILING
	1'x4' - (2) T8 LAMPS, VOLUMETRIC LUMINAIRE WITH CENTER DIFFUSER, RECESSED MOUNTED LUMINAIRE (IC-RATED) IN CONTACT WITH INSULATION ABOVE CEILING
	2'x4' - (4) T8 LAMPS, CLEANROOM, SEALED RECESSED MOUNTED LUMINAIRE (NSF-RATED)(IC-RATED) IN CONTACT WITH INSULATION ABOVE CEILING
	1'x4' - (3) T8 LAMPS, LENSED LUMINAIRE WITH GASKET, RECESSED MOUNTED LUMINAIRE (IC-RATED) IN CONTACT WITH INSULATION ABOVE CEILING
	(7) LEDS, LOW WATTAGE, DIMMABLE LED TRACK FIXTURE (SURFACE MOUNTED TRACK)
	LED, LOW WATTAGE, DIMMABLE, LOUVERED STEP LIGHT, RECESSED WALL LUMINAIRE
	LED, LOW WATTAGE, EXIT AND EMERGENCY COMBO, WALL MOUNTED FIXTURE
	(3) LEDS, LOW WATTAGE, OUTDOOR EGRESS LUMINAIRE, SURFACE MOUNTED FIXTURE
	CERAMIC METAL HALIDE, EXTERIOR WALL PACK, SURFACE MOUNTED FIXTURE
GENERAL RCP NOTES:	
1) ALL FIXTURE HEIGHTS INCLUDED ON THIS SHEET ARE FROM FINISH FLOOR TO THE BOTTOM OF EACH FIXTURE.	
2) CONTRACTOR TO COORDINATE ALL WALL LOCATIONS, HEIGHTS & THICKNESSES WITH STRUCTURAL DRAWINGS. CONTRACTOR TO ALSO COORDINATE ALL ATTIC ACCESS LOCATIONS, HEADER LOCATIONS & SIZES WITH THE STRUCTURAL DRAWINGS.	
3) CONTRACTOR TO COORDINATE CEILING HEIGHTS IN GREAT ROOMS AND MULTI-PURPOSE ROOM WITH STRUCTURAL DRAWINGS.	
4) REFER TO MEP DRAWINGS FOR MORE DETAILED SPECIFICATIONS & REQUIREMENTS ON LIGHTING FIXTURES.	
5) ALL PENETRATIONS THROUGH 1 & 2 HOUR FIREWALLS AND 1 HOUR RATED CEILING NEEDS TO BE FIRE SEALED PER CODE TO MAINTAIN THE INTEGRITY OF THE FIRE ASSEMBLY.	
6) CONTRACTORS TO COORDINATE FAN & LIGHT INSTALLATION AS NECESSARY TO PREVENT OR MINIMIZE THE AMOUNT OF LIGHT STROBING IN ALL GREAT ROOMS AND THE MULTI-PURPOSE ROOM.	

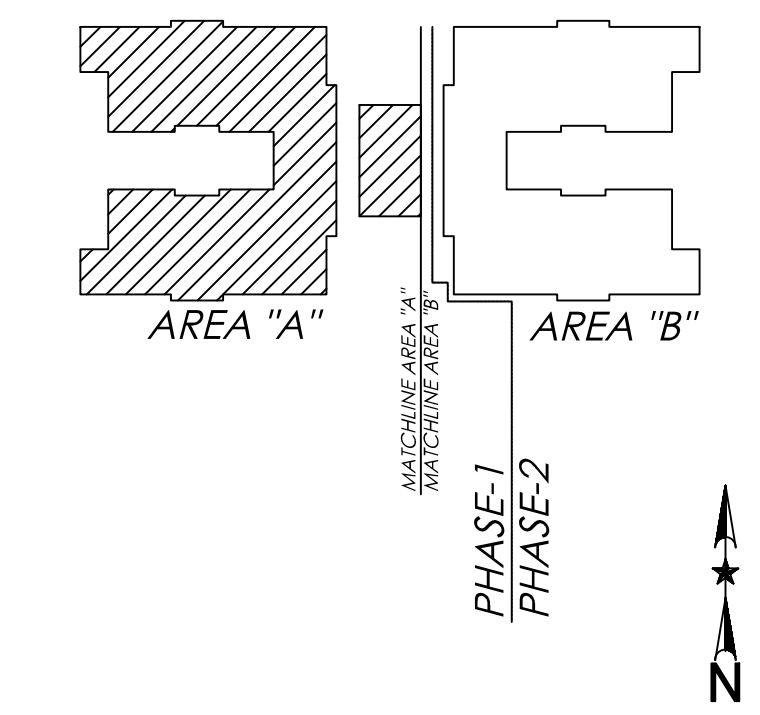

KEY PLAN  
SCALE: N.T.S.

Optimum Personal Care  
Assisted Living Facilities  
1110/12/14 Lakeview Dr.  
Sugar Land, Texas 77478

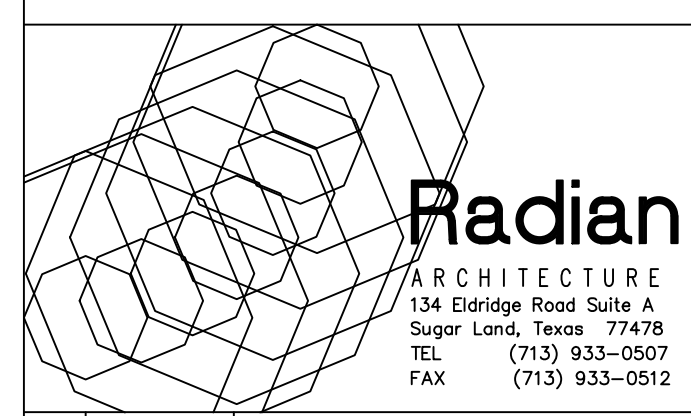

#	Date	Description
1	12.10.12	SCHEMATIC DESIGN
2	02.28.13	50% CONSTRUCTION DOCS.
3	05.30.13	CONTRACTOR SET
4	08.14.13	CONTRACTOR SET - #2
5	08.30.13	PERMIT / TDADS SETS
6	09.10.13	ACI CHANGES
7	11.25.13	TDADS COMMENTS
8	12.10.13	CITY COMMENTS
9	01.23.14	CITY COMMENTS
10	07.17.14	DOORS/WINDOWS REV.
11	08.20.14	FIRE SCREEN WALL
12	10.14.14	PERMIT SET #2
13	07.07.15	GREAT RM. MILLWORK
14	08.07.15	MILLWORK CLARIFICATION
15	08.31.15	COURTYARD REPLACEMENT



Project No. 1201.31  
REFLECTED CEILING PLAN  
Sheet No.

A4.0