



File Name: M:\Radian Architecture\12523.00 Optimum Care - Sugar Land\Plumb\12523.00 PLUMBING.rvt  
 User: Author  
 Date/Time: 4/8/2013 4:33:03 PM

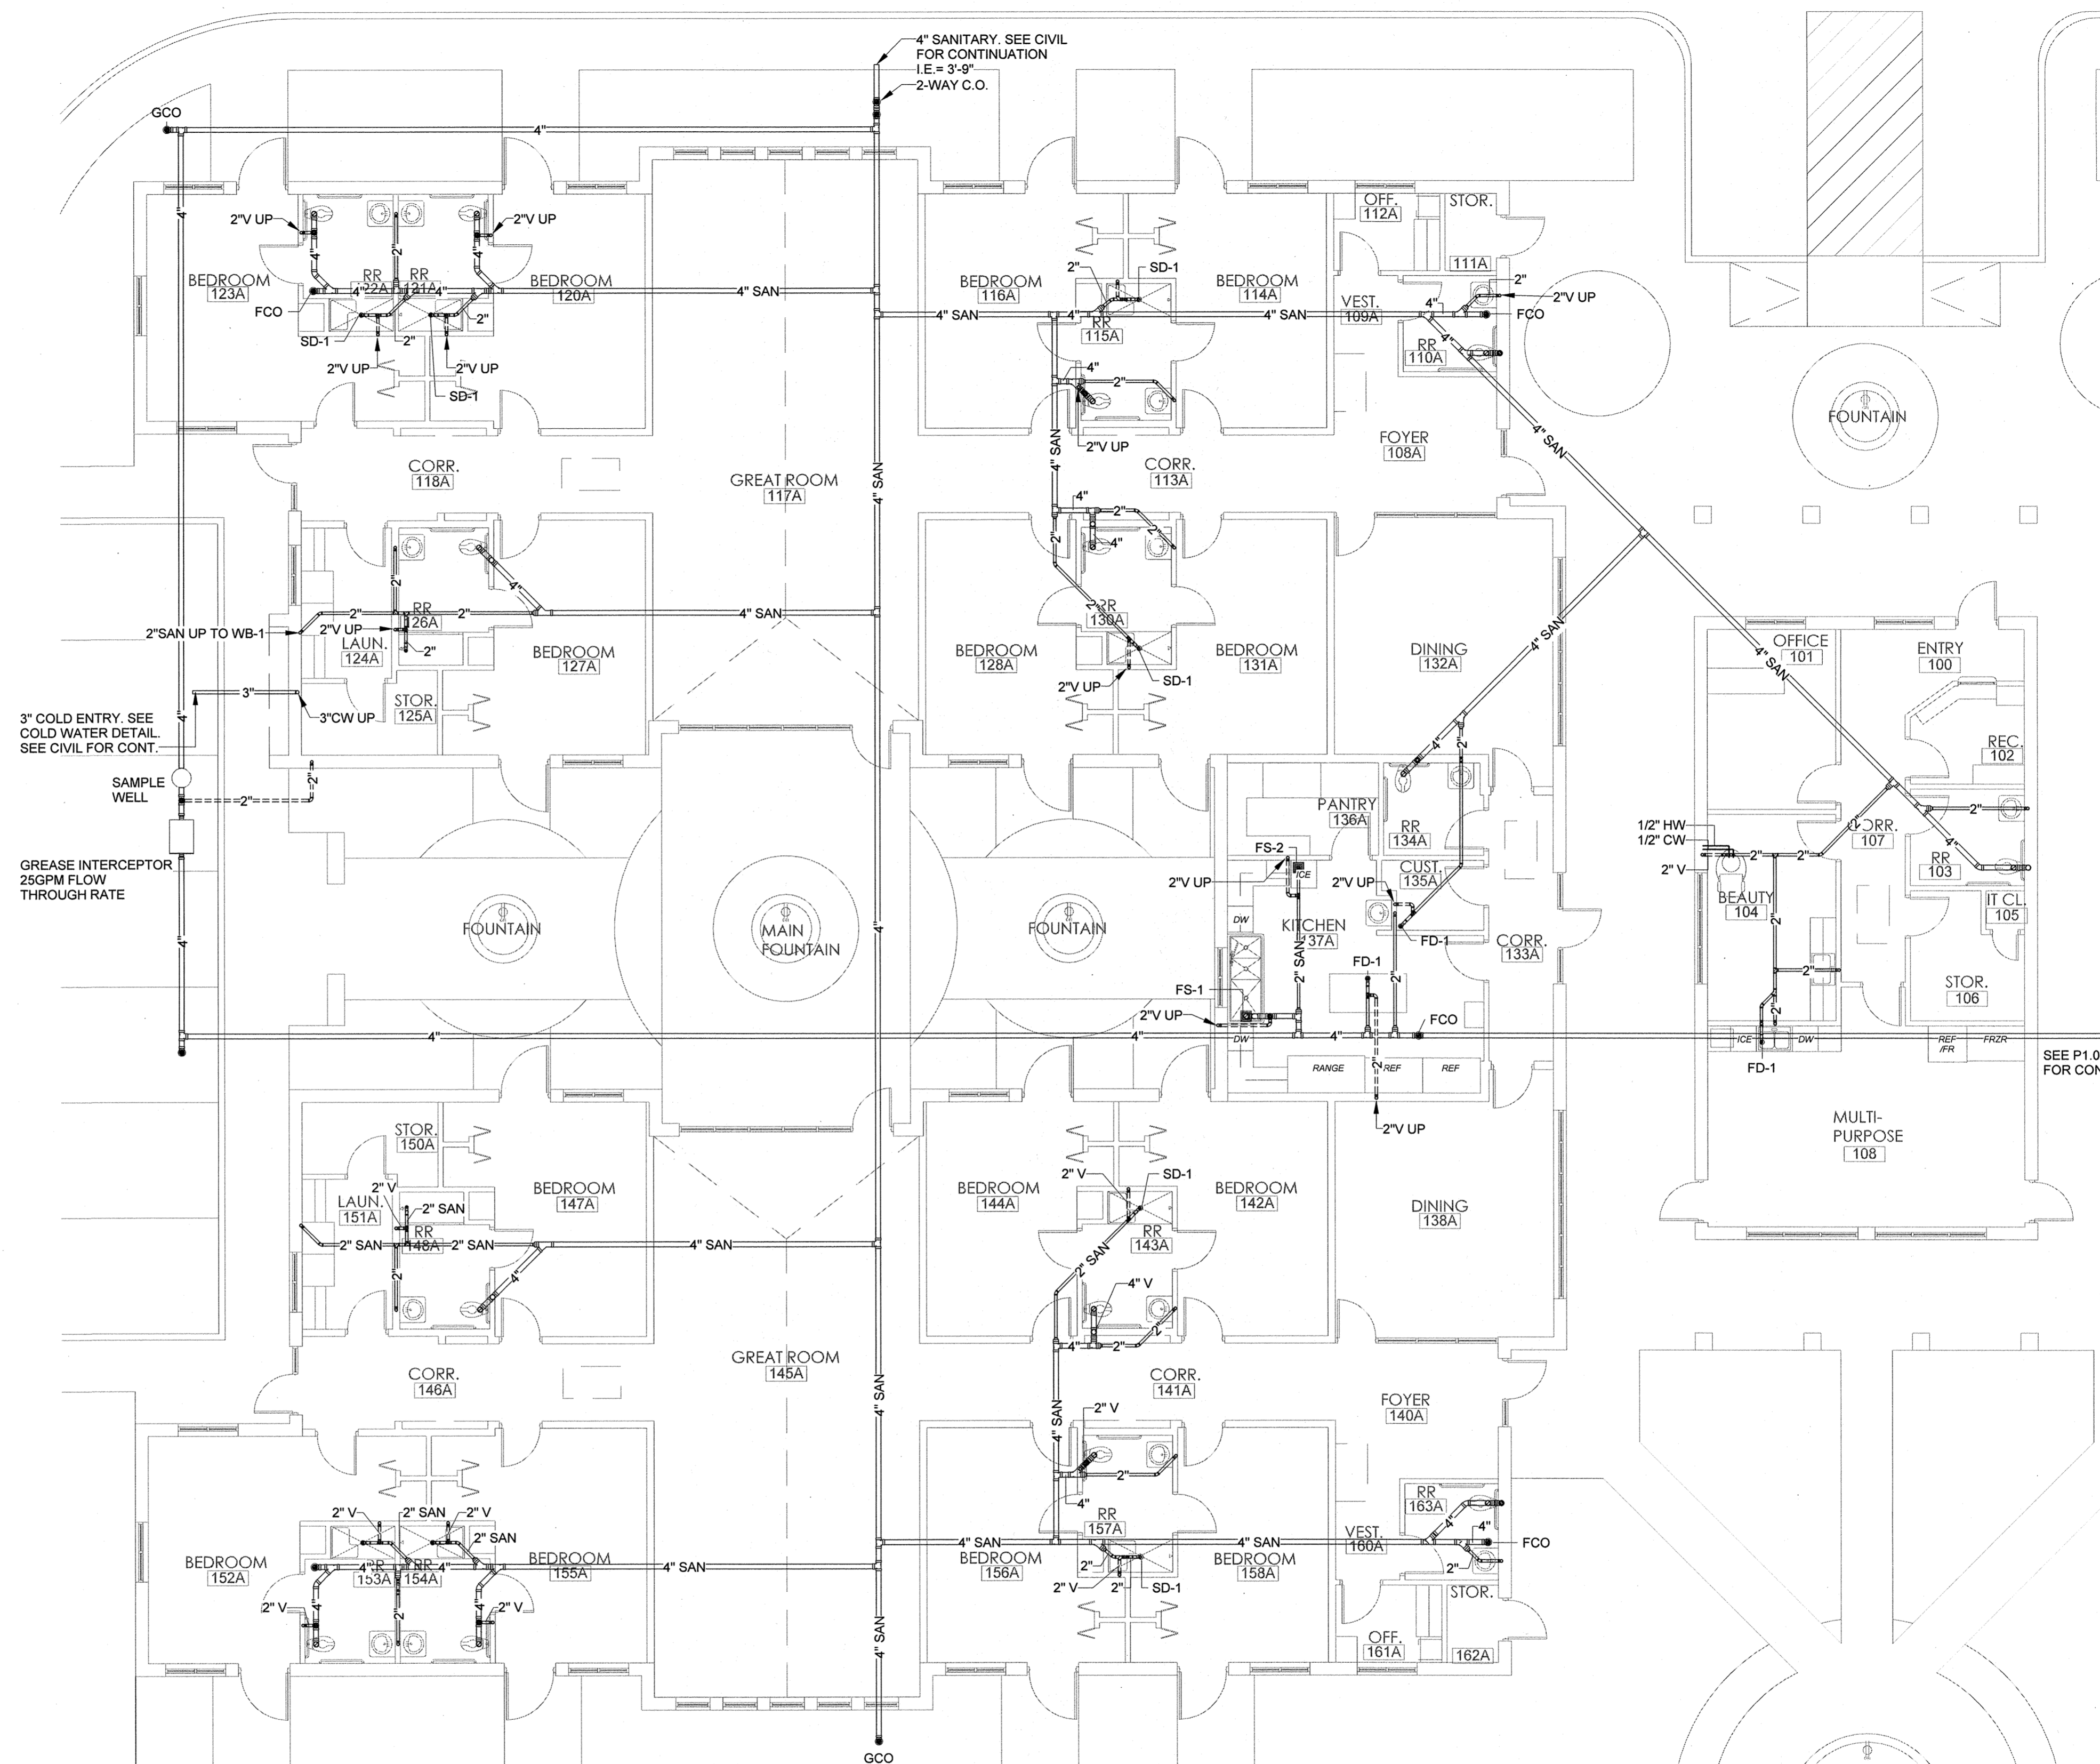

**1** PLUMBING PLAN - AREA A - BELOW FLOOR  
 1/8" = 1'-0"


**KEYED NOTES**

**OPTIMUM CARE  
 SUGAR LAND, TEXAS**

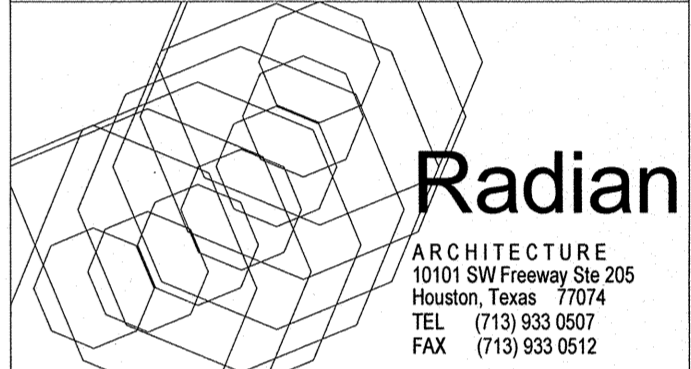

**Revision Schedule**

#	Date	Description

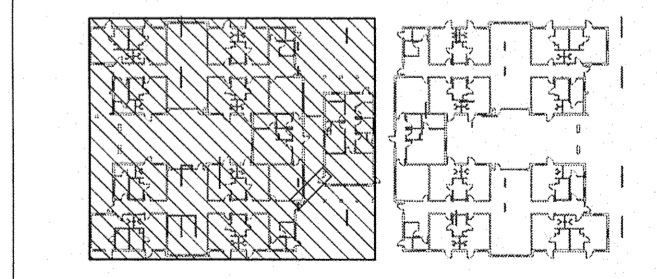

Project No.  
 PLUMBING PLAN - AREA A - BELOW FLOOR  
 Sheet No.

**REDDING  
 LINDEN  
 BARR**  
 CONSULTING ENGINEERS  
 801 TRAVIS, SUITE 2000  
 HOUSTON, TEXAS 77002  
 PH: 713.237.9800  
 FAX: 713.237.9801  
 TEXAS REGISTERED ENGINEERING FIRM F-3113

**P1.01**